


REV.	DESCRIPTION	BY	DATE	APPROVED
0	FIRST ISSUE	A.N.	13-11-07	
1	FINAL	A.N.	03-03-08	


**COLLEGAMENTO ELETTRICO
E TUBO DI SUPPORTO
ALLA CENTRALINA
DA EFFETTUARE**

LEGENDA		
SYMBOL	ITEM	DESCRIPTION
	B1- B2	CO2 RECEIVER
	TP.01	MANUAL ACTUATOR
	4-SOV-	ELECTROVALVE
	CV.01	NO RETURN VALVE
	VS.01	VENT VALVE
	4-PSH-	PRESSURE SWITCH
	C 01-06	CO2 NOZZLES
	FCP.01	CONTROL PANEL
		CO2 PIPES
		PNEUMATIC CONNECTION
		ELECTRIC CONTROL LINE
	4-XL-	OPTICAL SIGNAL (RED OPTICAL BEACONS)
	4-GD-	GAS DETECTOR
	4-FD-	FLAME DETECTOR
	4-HS-	CO2 DISCHARGE MANUAL PUSH BUTTON
	4-XA-	OPTICAL AUDIBLE ALARM

Edited by Foxit Reader
Copyright(C) by Foxit Software Company, 2005-2018
For Evaluation Only.

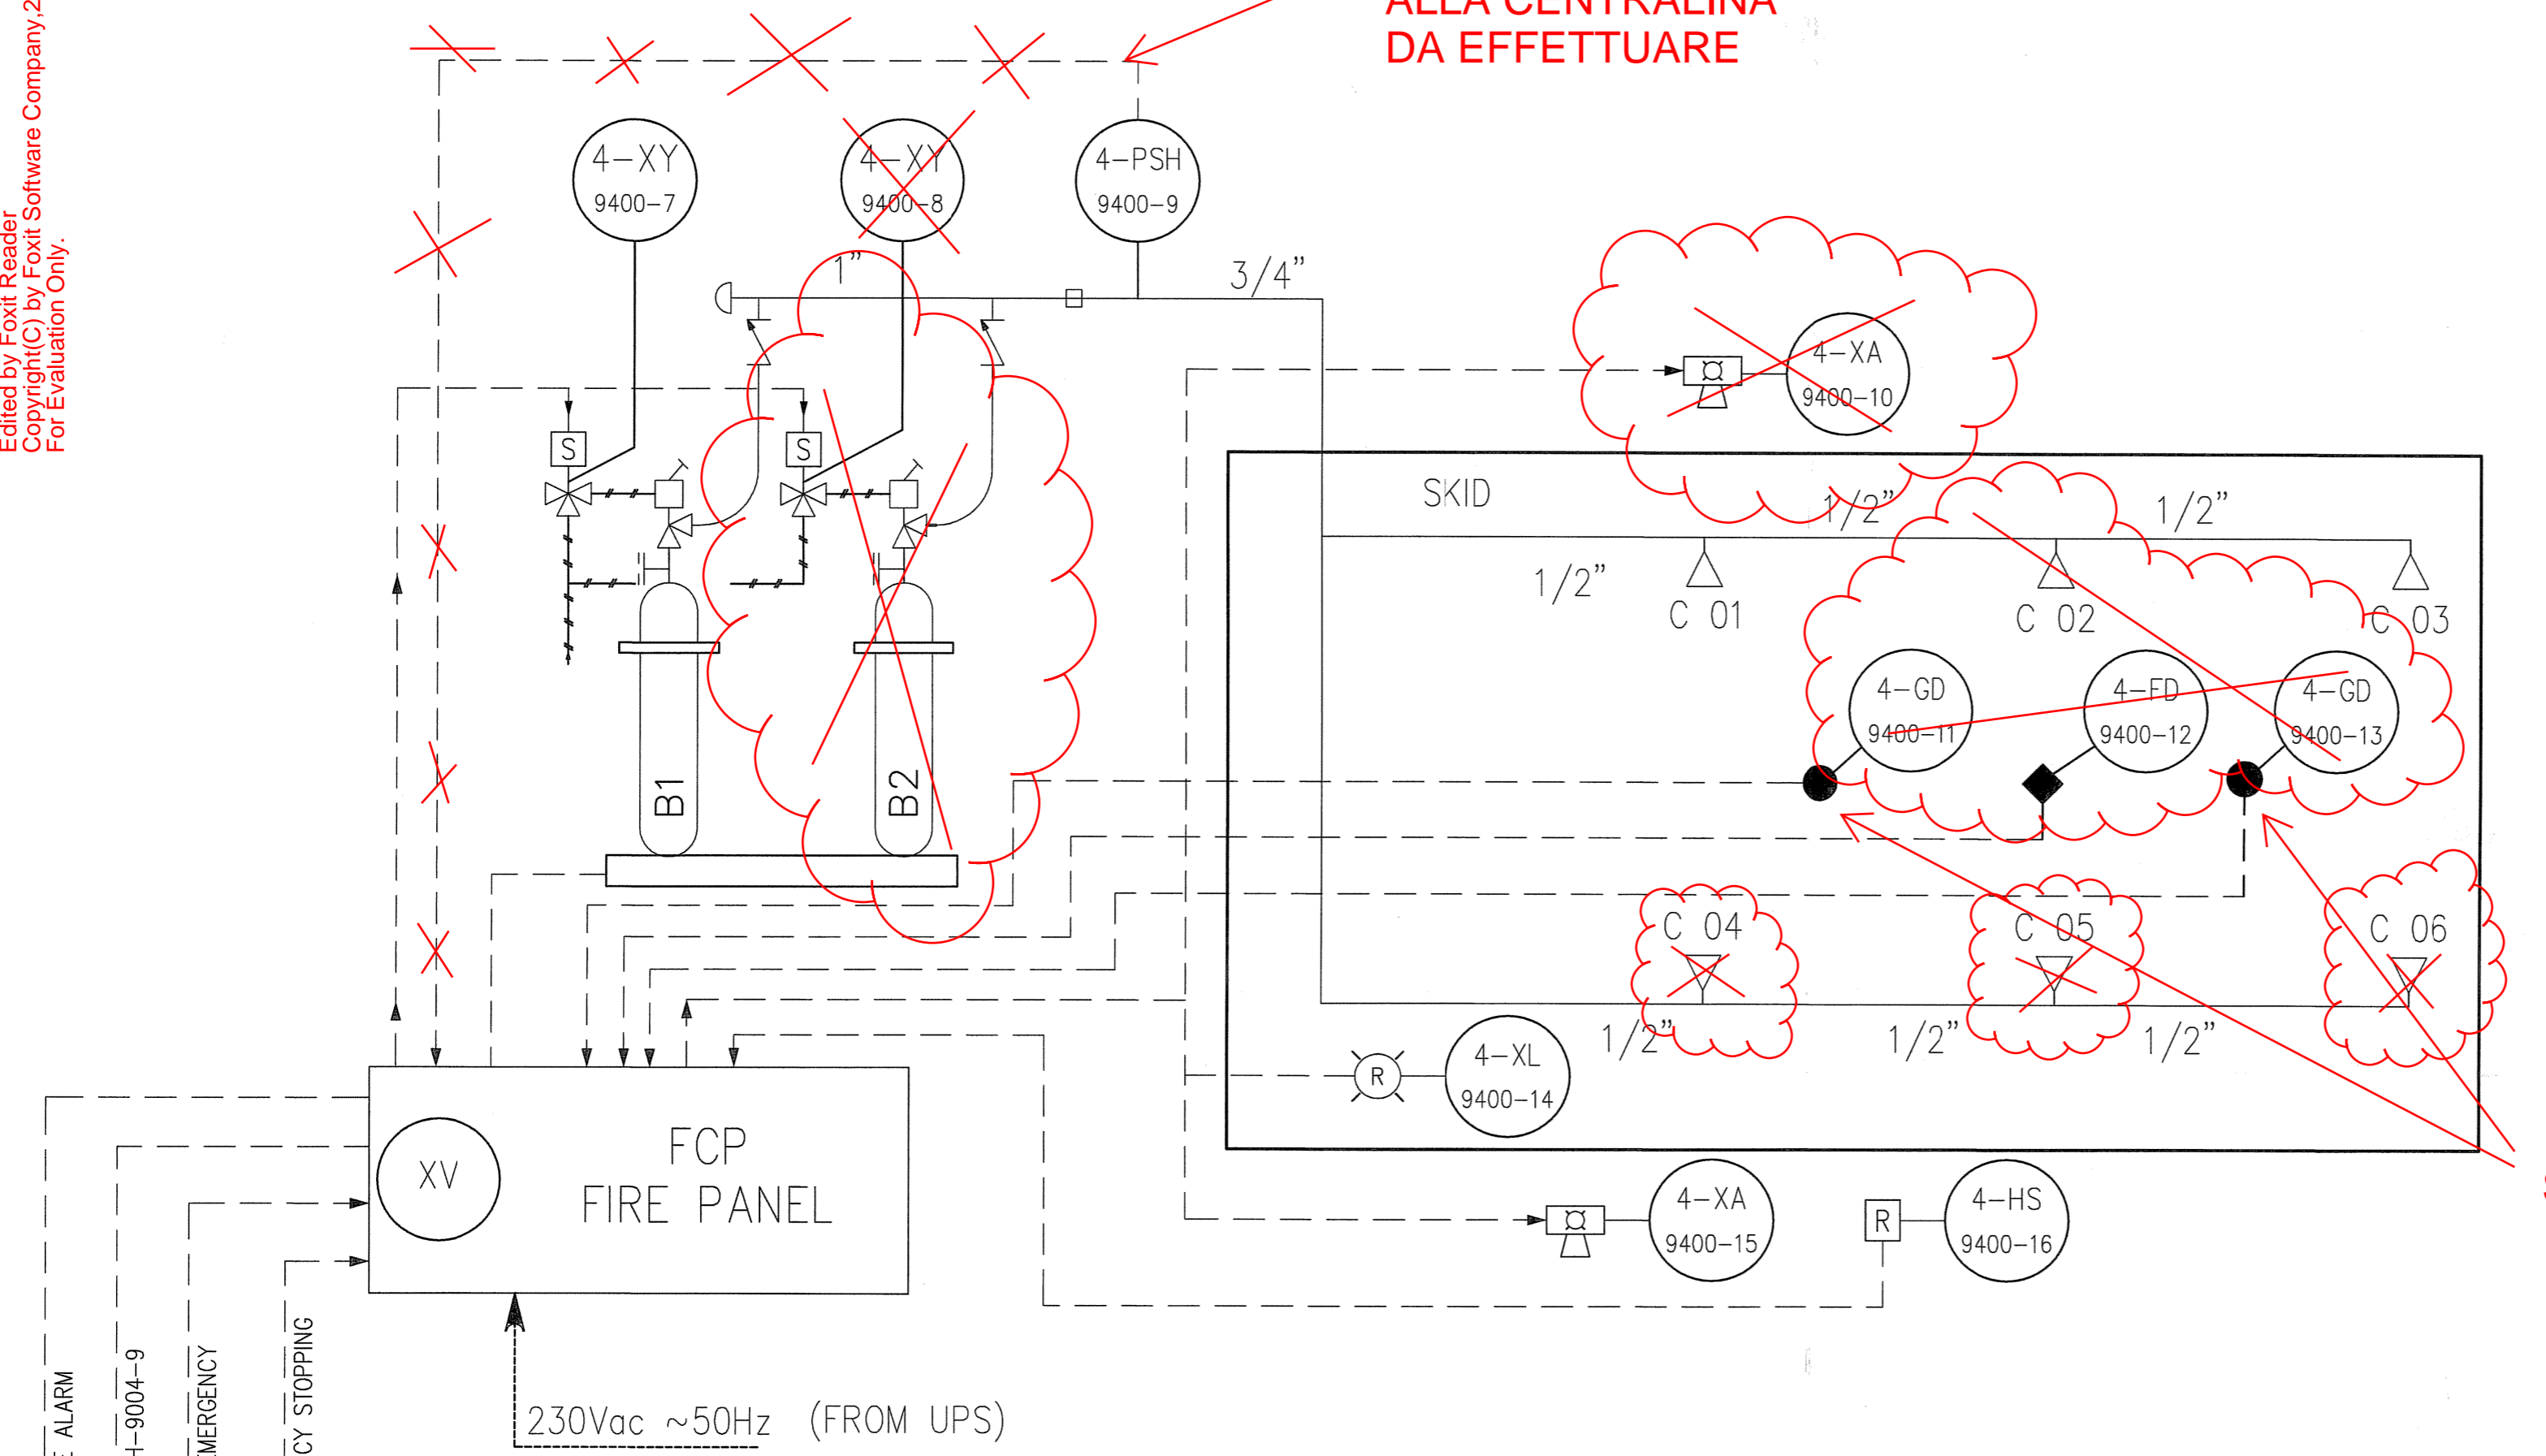

SONO PRESENTI DUE SENSORI TERMICI

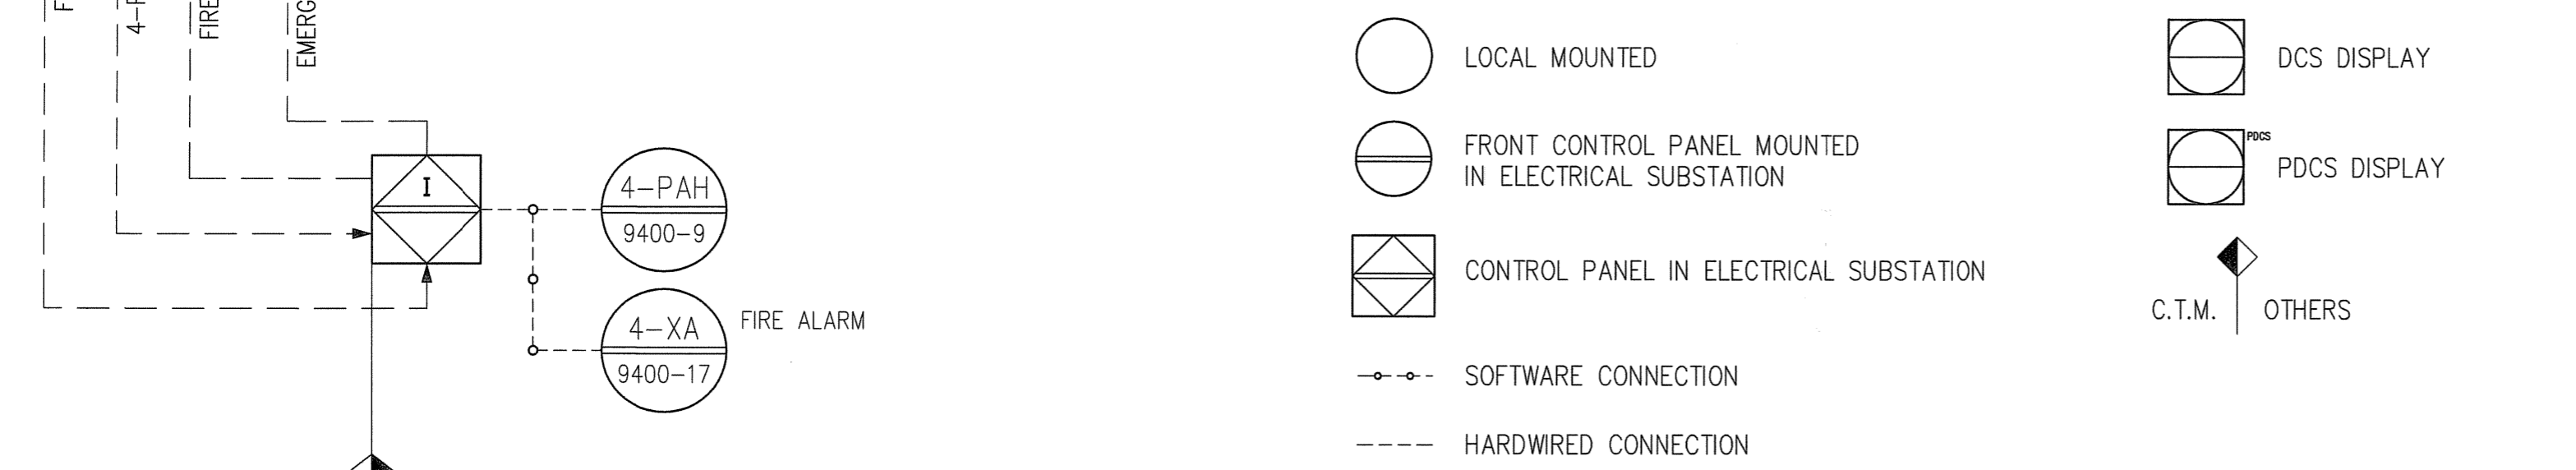

Snamprogetti S.p.A.		
DOCUMENT STATUS	SIGNED	DATE
A - INFORMATION / COMMENTS NOTED SUBMIT CERTIFIED FINAL		
B - INFORMATION / COMMENTS NOTED REQUIRIT		
IO - FOR INFORMATION ONLY NO REVIEW PERFORMED		
SCF - SUPPLIER CERTIFIED FINAL		

ISSUE OF CERTIFIED FINAL DOCUMENT DOES NOT RELIEVE SUPPLIER OF RESPONSIBILITY OR LIABILITY UNDER THE CONTRACT / PURCHASE ORDER

 	PROJECT	QATOFIN LLDPE PLANT		
	CONTRACTOR JOB No.	315300	REV.	DATE
	P. O. No.	24584	0	12.11.07
	DWG. / SPC No.	90-PD-C-97265	1	03.03.08
Sh 1 of 1		DAPCD DWG No. -----		

TOLLERANCES EXCEPT WHERE OTHERWISE STATED 0 - 500mm. ± 1mm. 500-2000mm. ± 2mm. OVER 2000mm. ± 3mm. STRUCTURAL ± 3mm. ANGULAR ± 0,5°	 compagnia tecnica motori Compagnia Tecnica Motori S.p.a. I-20090 Cesano boscone (Milano) Via Magellano, 1 Telefono 02/450581 (20 linee r.a.) Telefax 02/45058260 - 02/45058262 e-mail: ctm@ctm.it	DRN. BY	A.N.
		DATE	13-11-07
THIS DRAWING AND THE DESIGN SHOWN ARE THE PROPERTY OF CTM S.p.a. AND MUST NOT BE USED OR COPIED WITHOUT THEIR PERMISSION ALL DIMENSIONS IN MILLIMETRES UNLESS OTHERWISE STATED		APPD. BY	
DO NOT SCALE		DATE	

CLIENT	SNAMPROGETTI SPA		
ORDER N°:	6600		
TITLE	P&ID FIRE FIGHTING SYSTEM		
SHEET SIZE	ORIGINAL SCALE	DRAWING N°:	REV.
A2	/	6600-P-703	1