


EQUIPMENT LIST	
ITEM	DESCRIPTION
1	FM200 RECEIVER 60L. (40kg)
2	VALVE 2"
3	CONNECTION PIPE
4	ELECTRIC ACTUATOR
5	FLEXIBLE PIPE 2"
6	FLEXIBLE PIPE 3/4"
7	PRESSURE SWITCH
8	VALVE
9	GALVANIZED NIPPLES S.3000 1"1/2 GAS
10	GALVANIZED TE S.3000 1"x1"1/2x1" GAS
11	GALVANIZED REDUCER S.3000-6000 1"x1/2" GAS
12	-
13	PULLEY
14	PANEL HAND PULL CONTROL
15	GALVANIZED PIPE SCH.40 1" API 5L GR.B
16	NOZZLE 1/2"

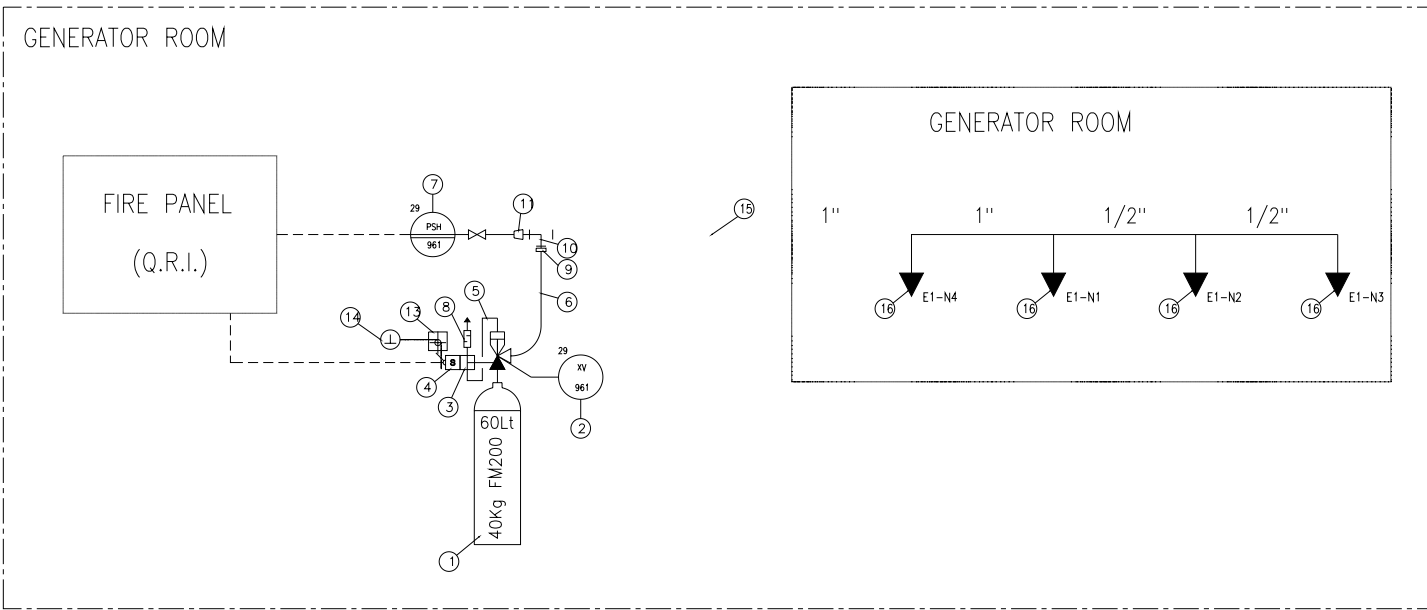

REV.	DATE	DESCRIPTION	COMP.	DESIGN.	CHK.	APP.
2	15-12-08	FOR FINAL	M.B.	M.Bald	F.Baroni	G.Bono
1	30-09-08	FOR FINAL	M.B.	M.Bald	F.Baroni	G.Bono
0	20-11-07	FIRST ISSUE	M.B.	M.Bald	F.Baroni	G.Bono

compagnia tecnica motori
 Compagnia Tecnica Motori S.p.a.
 Via Magellano, 1
 40138 Bologna, Italy
 Tel: +39 051 260001 (20 linee r.a.)
 Fax: +39 051 260002 - 02/4500262
 e-mail: ctm@ctm.it

CLIENTE	GS	IMPIANTO	SALALAH	Fp	di	Scale / Scale
client		plant		Sheet	of	
TITOLO/Title	P&ID GAS EXTINGUISHING SYSTEM			REV.	0	1
				Doc. N.	943-M-011	

REV.	DATE	DESCRIPTION	COMP.	DESIGN.	CHK.	APP.
15-12-08	FOR FINAL		MB	MB	FB	GB
30-09-08	FOR FINAL		MB	MB	FB	GB
20-11-07	FIRST ISSUE		MB	MB	FB	GB

SALALAH METHANOL PROJECT
 Salalah, Sultanate of Oman

compagnia tecnica motori
GS E&C Corporation
 SEOUL, KOREA

P&ID GAS EXTINGUISHING SYSTEM
 (20-Z2902)

CLIENT	GS ENGINEERING	
ORDER N°	6608	
UNIT NO.	29	DRAWING NO.
SCALE	/	JOB. NO.
		7572

compagnia tecnica motori
 Compagnia Tecnica Motori S.p.a.
 Via Magellano, 1
 40138 Bologna, Italy
 Tel: +39 051 260001 (20 linee r.a.)
 Fax: +39 051 260002 - 02/4500262
 e-mail: ctm@ctm.it

THIS DRAWING AND THE DESIGN SHOWN ARE THE PROPERTY OF C.T.M. S.p.A. AND MUST NOT BE USED OR COPIED WITHOUT THEIR PERMISSION

DO NOT SCALE

ALL DIMENSIONS IN MILLIMETERS UNLESS OTHERWISE STATED

DRN. BY: A.N.
 DATE: 20-11-07
 APPD. BY:
 DATE:

3rd ANGLE PROJECTION

REV.	DESCRIPTION	BY	DATE	APPROVED
2	FOR FINAL	AN.	15-12-08	
1	FOR FINAL	AN.	30-09-08	
0	FIRST ISSUE	AN.	20-11-07	